




SECOND FLOOR PLAN

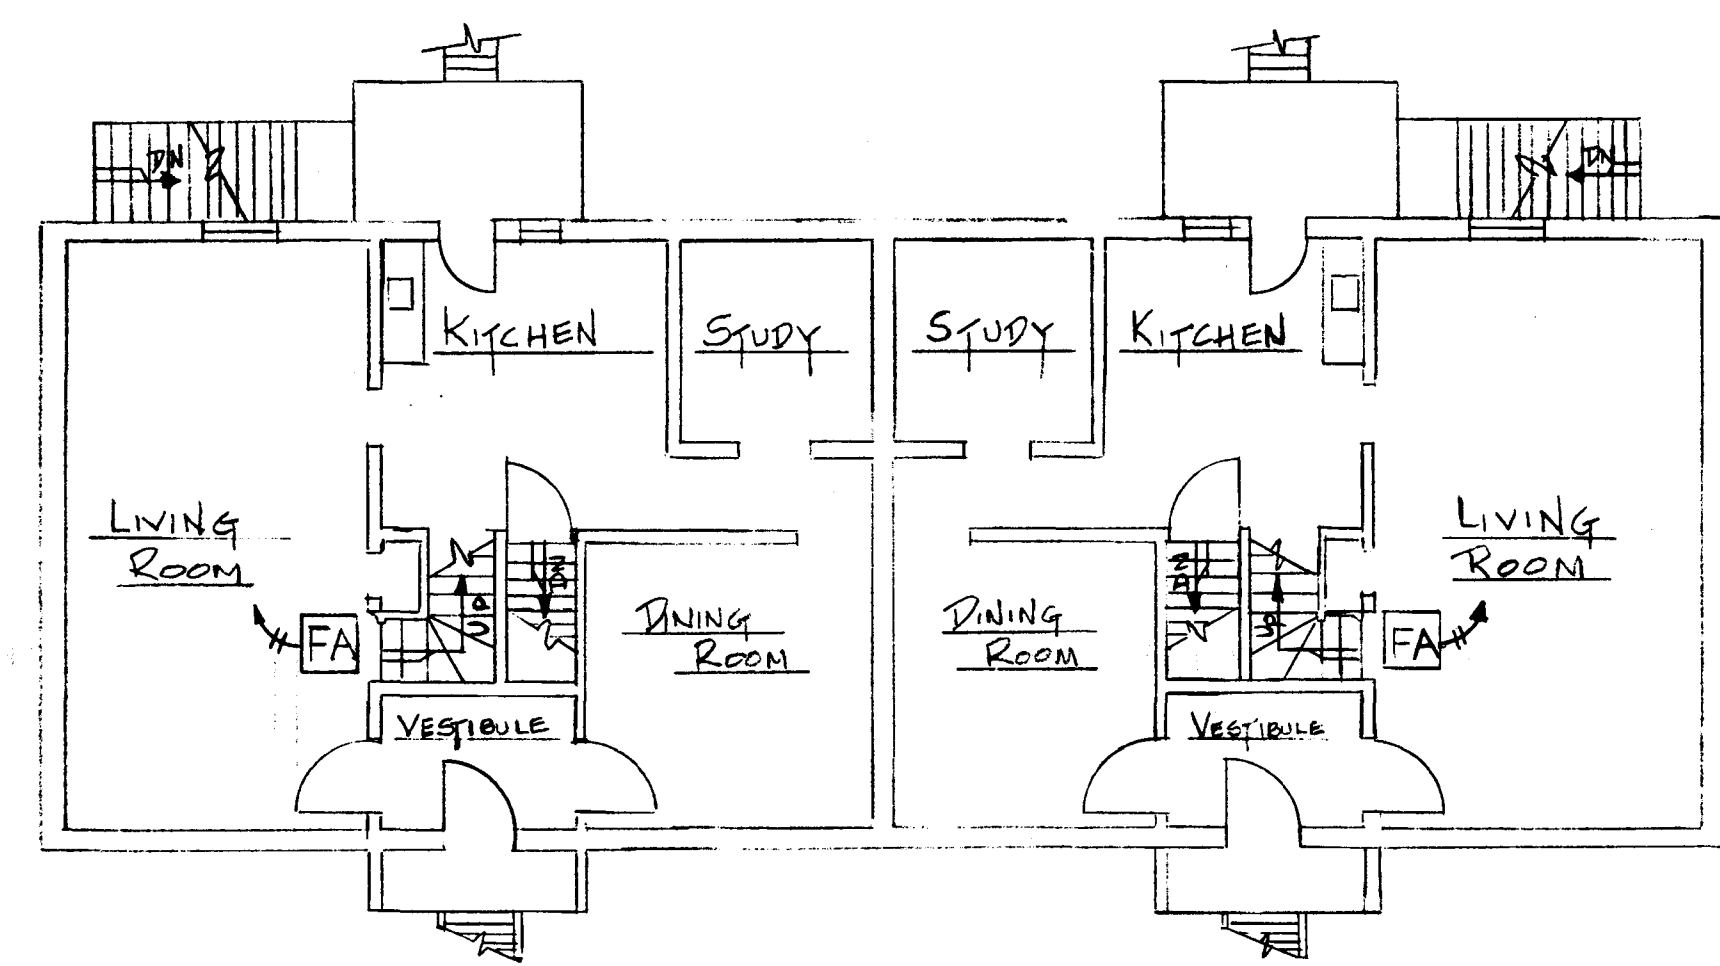


FIRST FLOOR PLAN

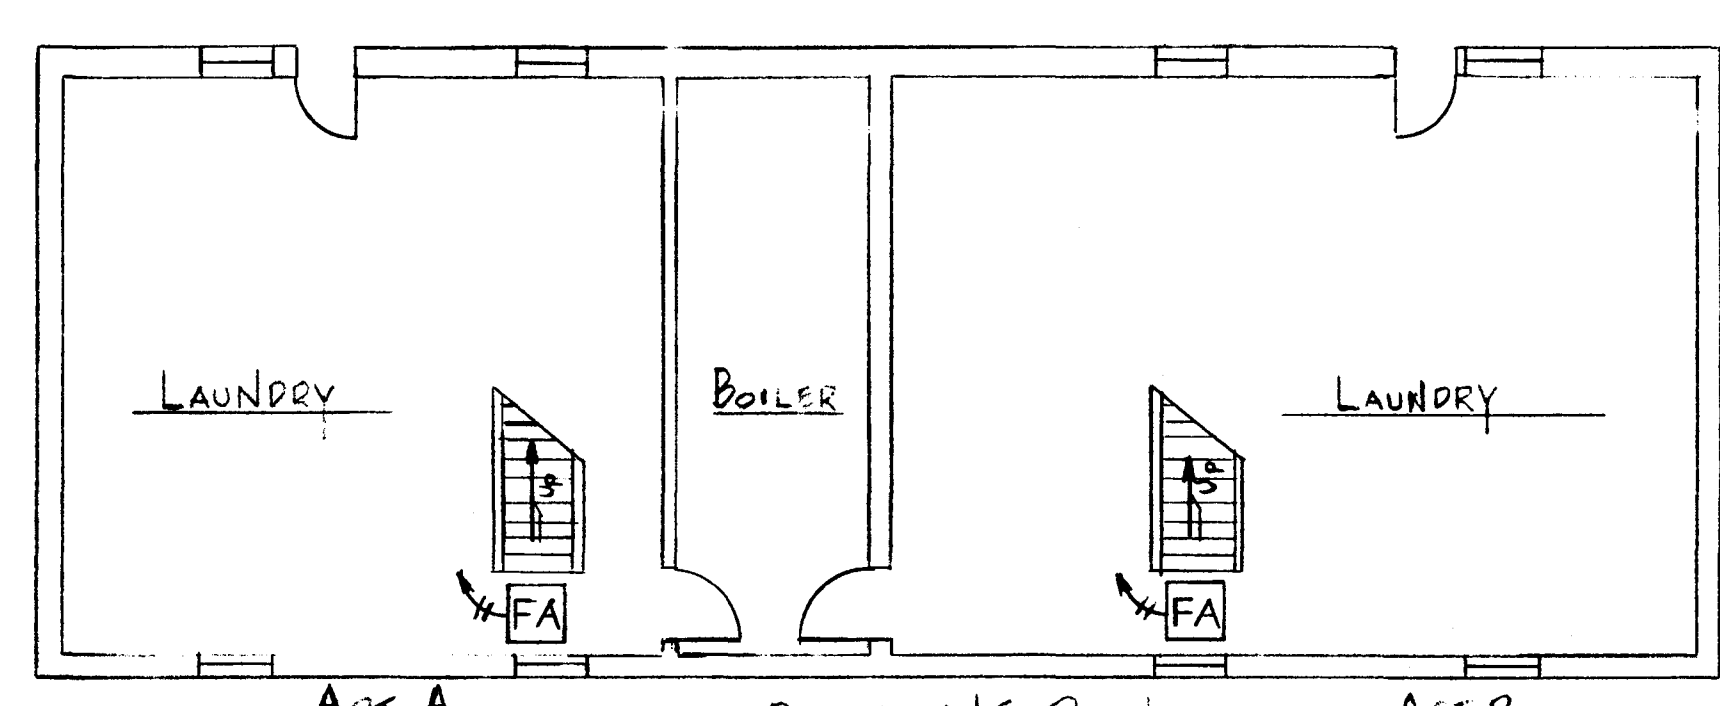


BASEMENT PLAN
FLOOR PLAN OF BLDG. 177

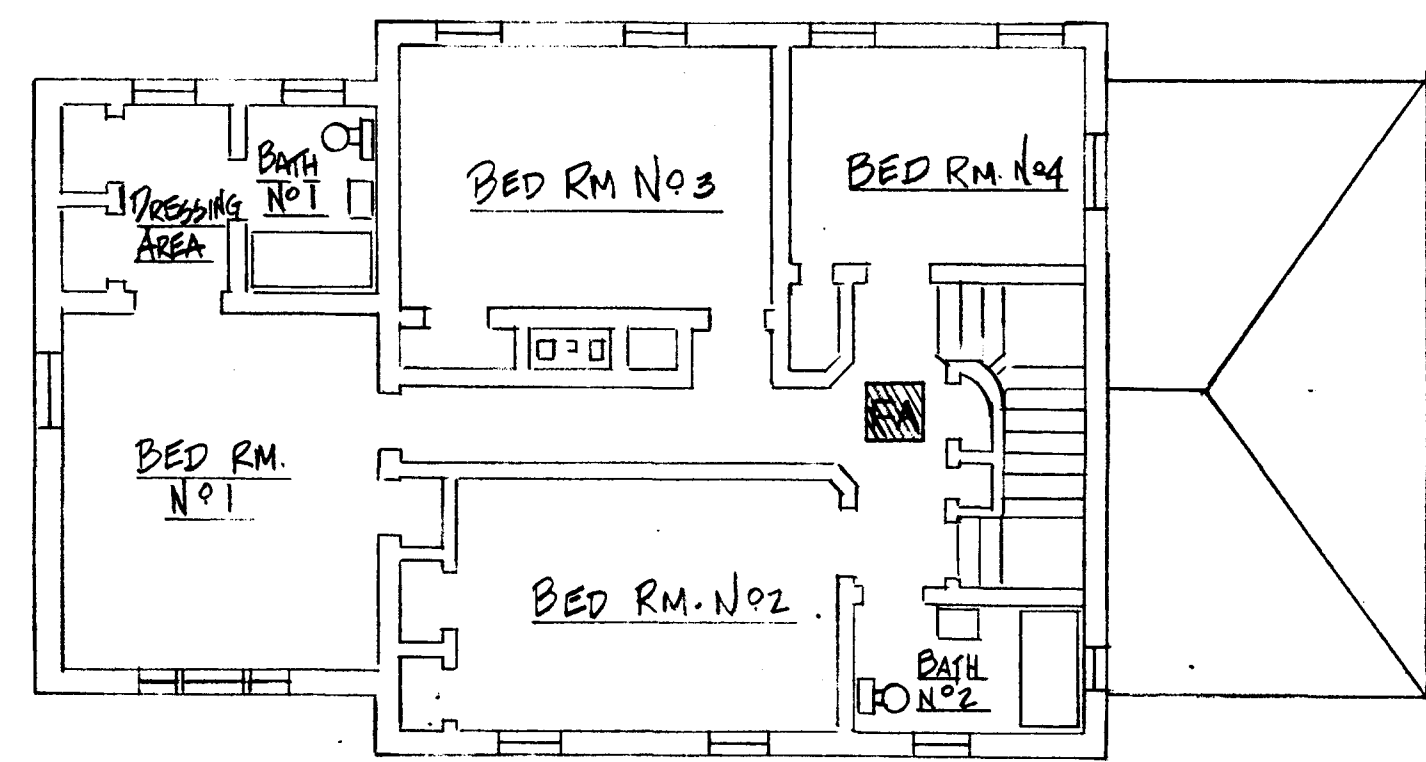

SECOND FLOOR PLAN

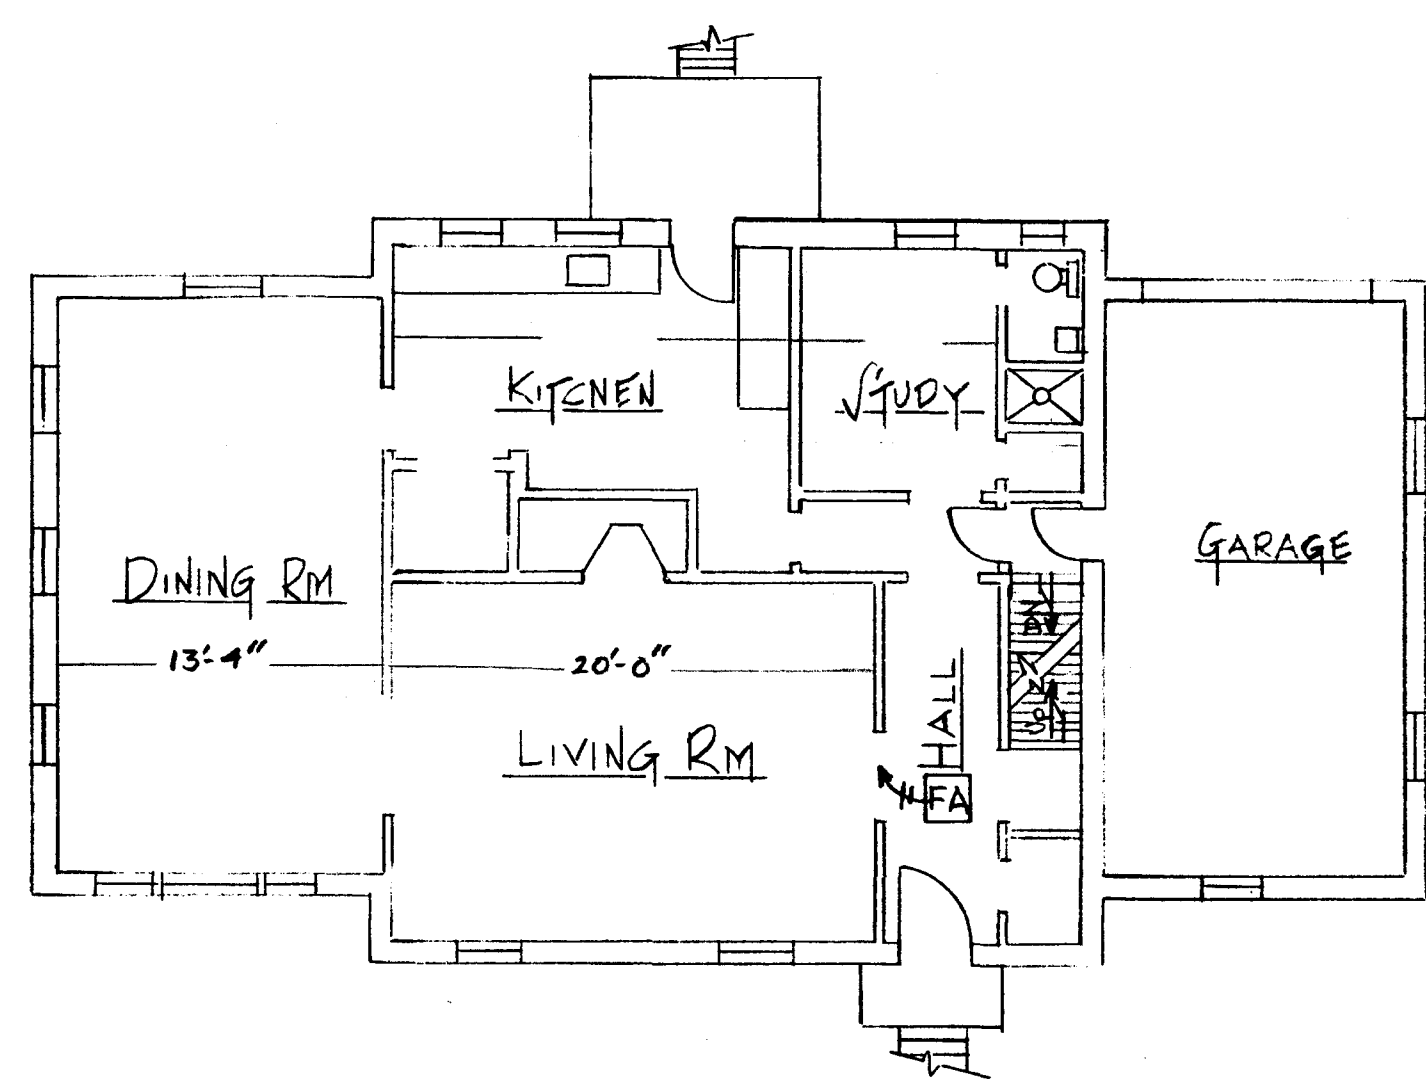


FIRST FLOOR PLAN

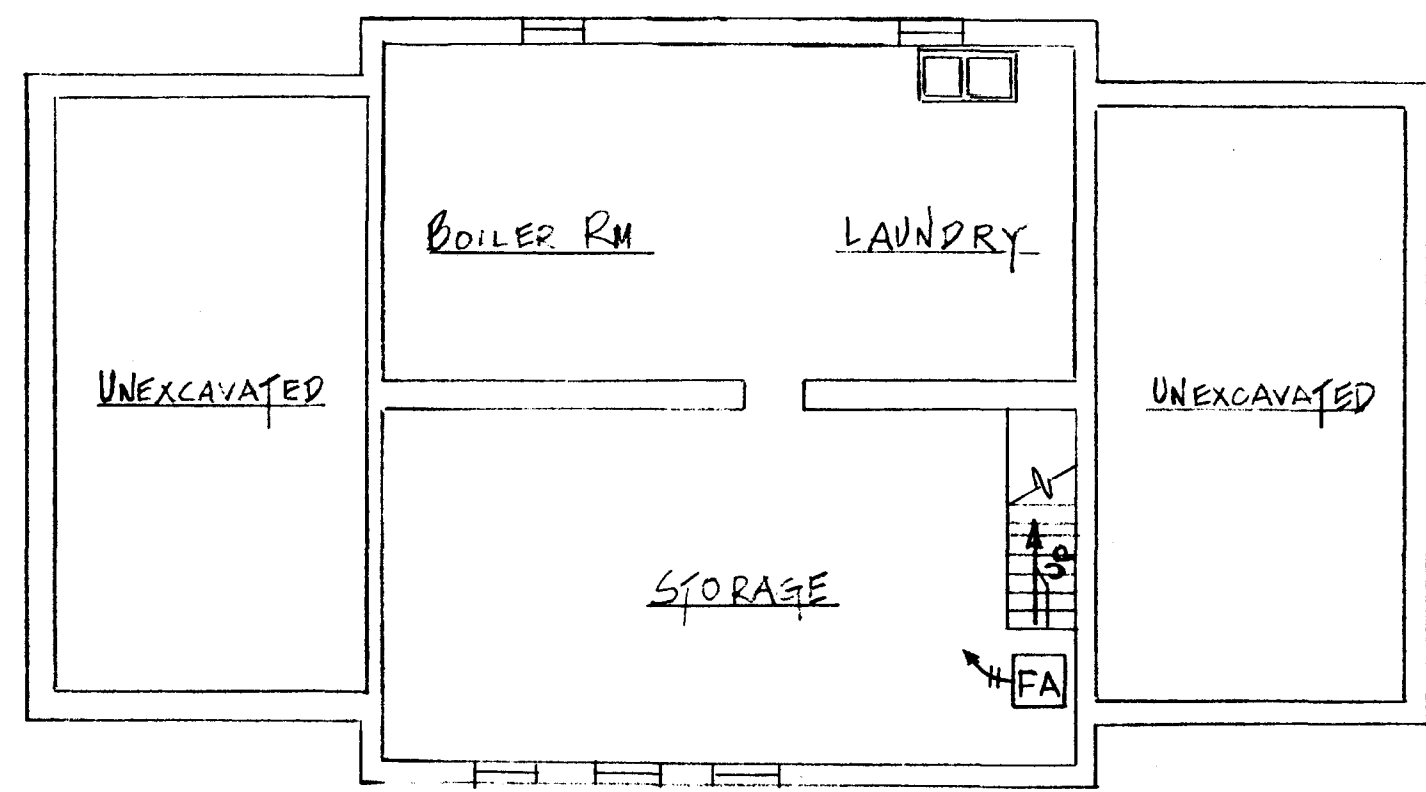

BASEMENT PLAN


FLOOR PLANS OF BLDG 179

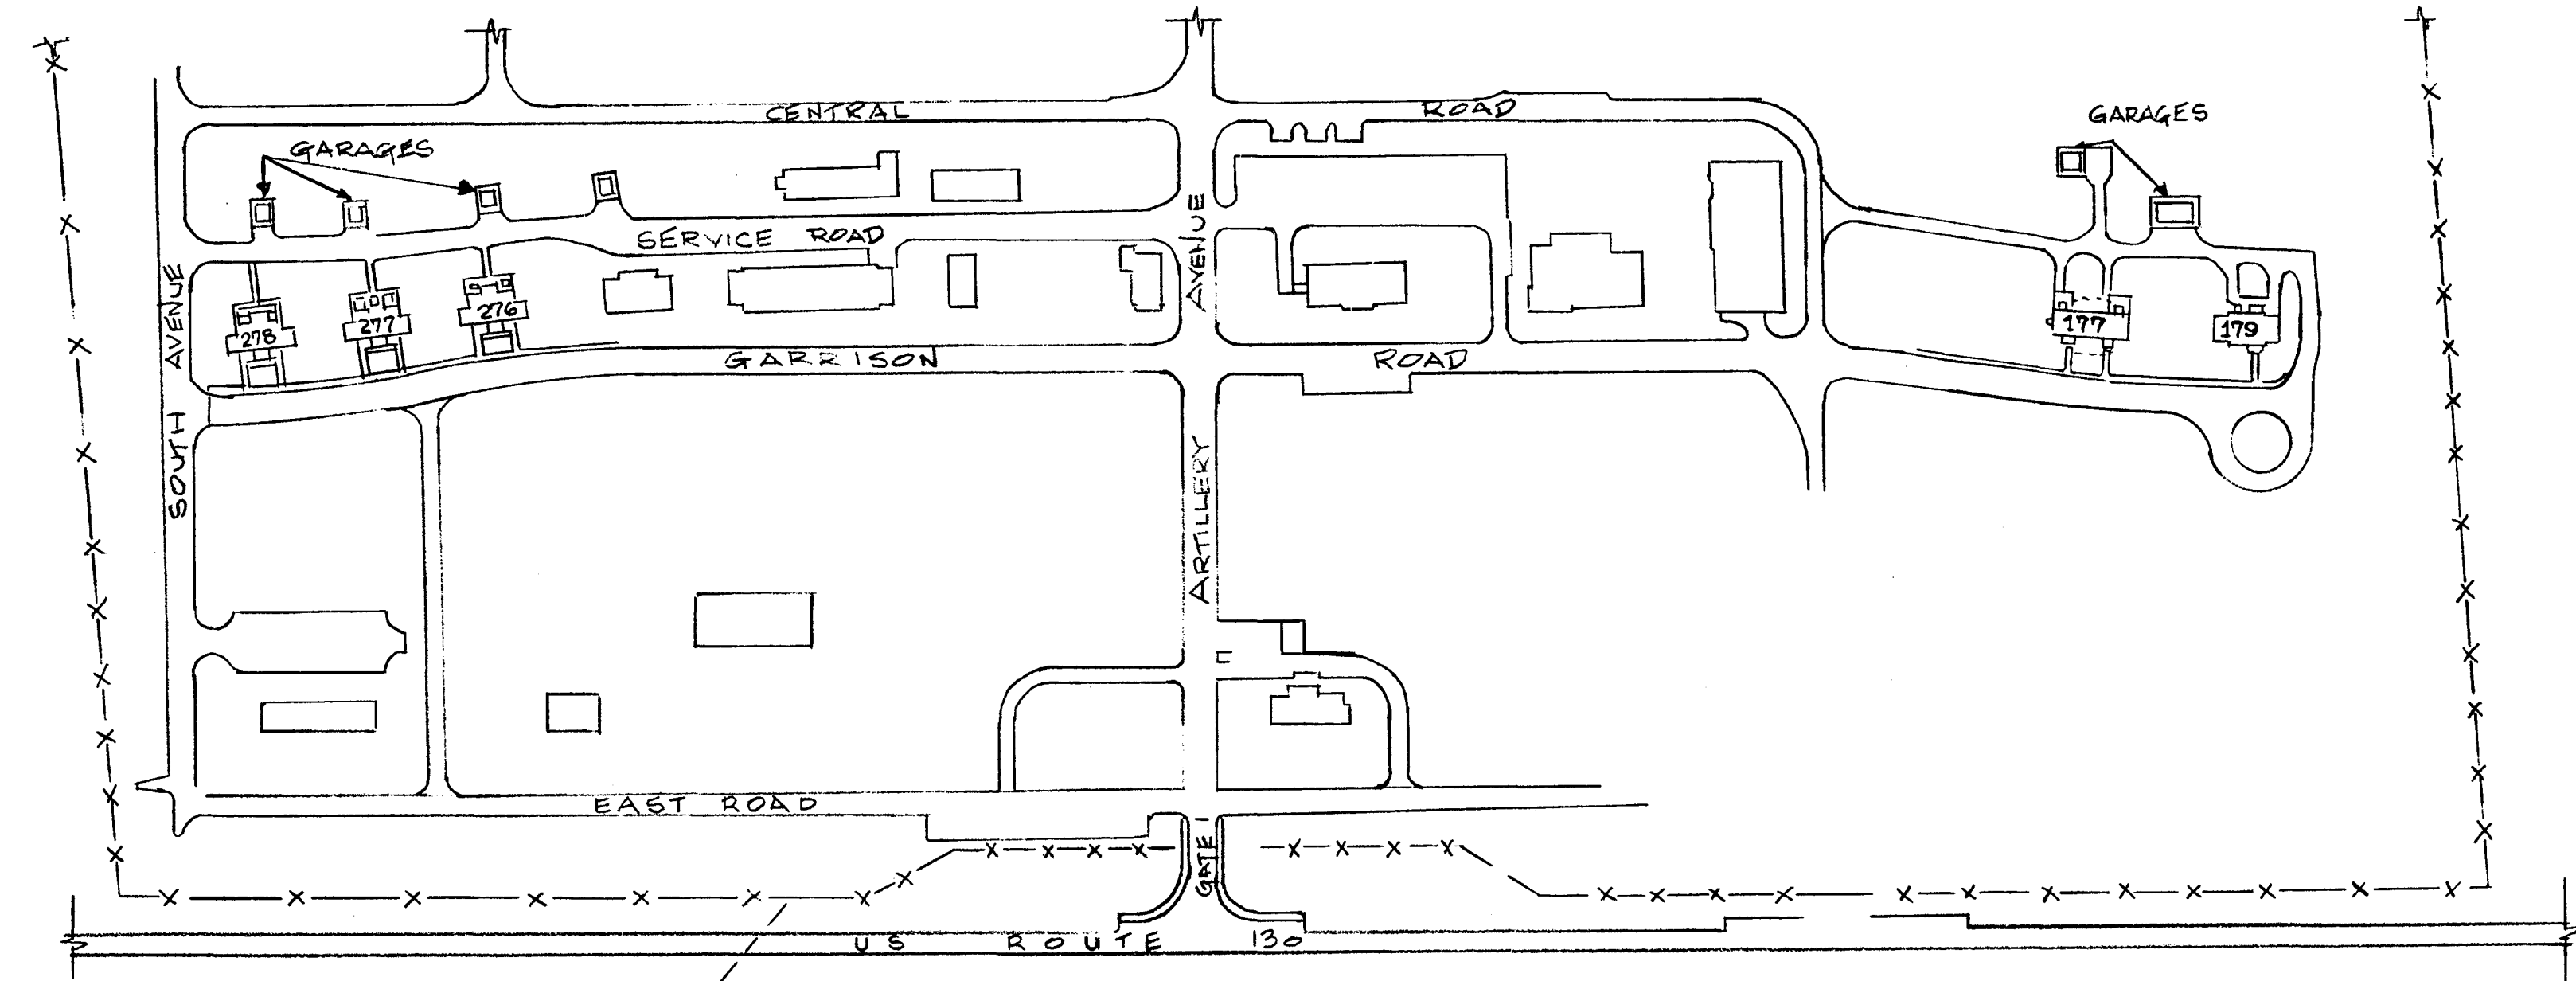


SCALE IN FEET
100' 200' 300'
GRAPHIC SCALE

SITE PLAN


NOTE :
FOR GENERAL NOTES AND
LEGEND SEE SHEET 2 OF 12

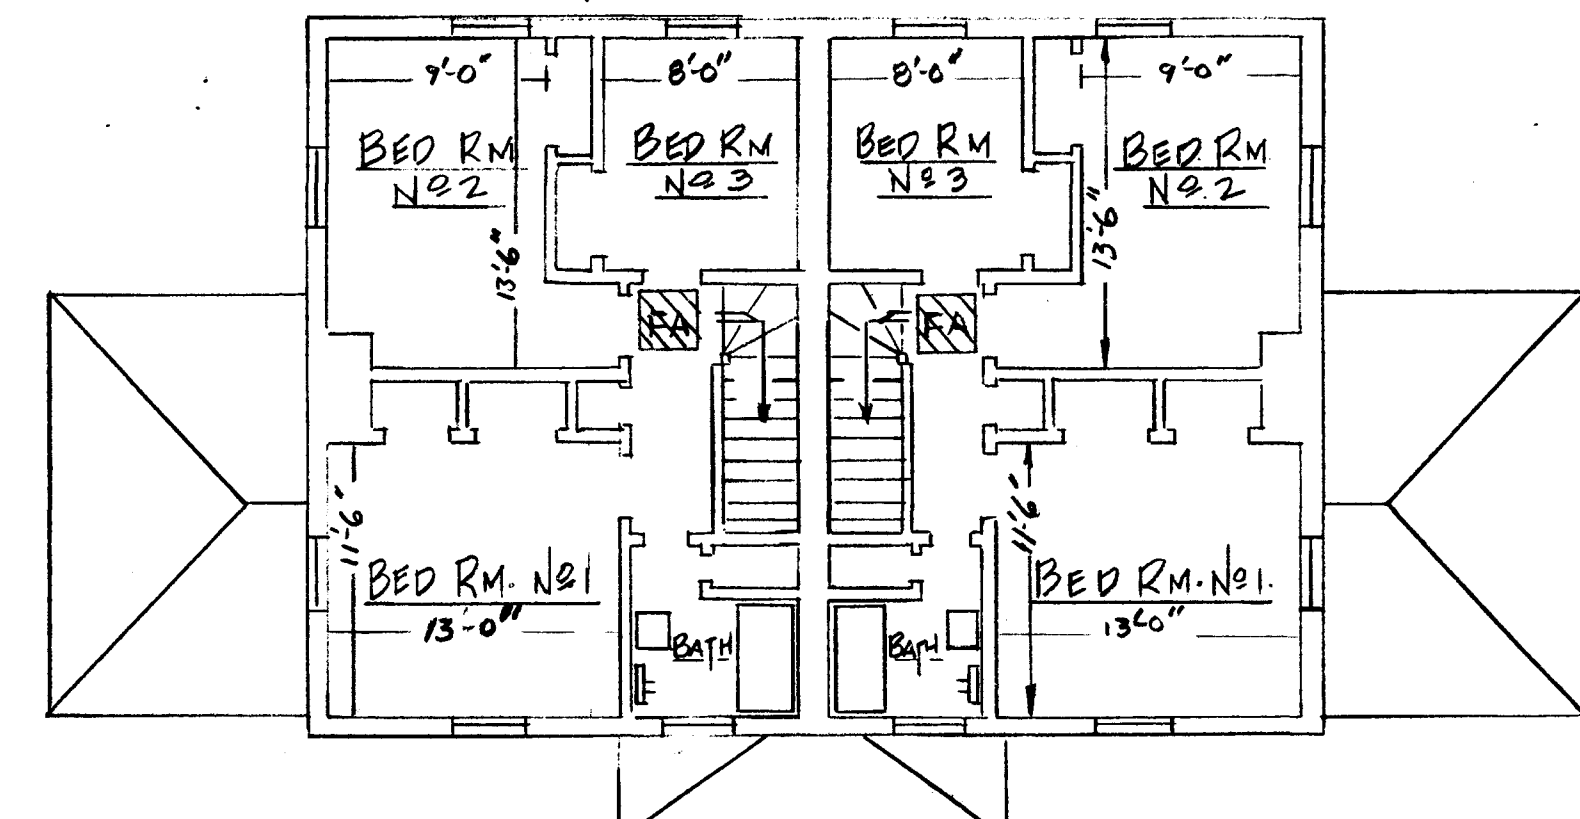

SECOND FLOOR PLAN

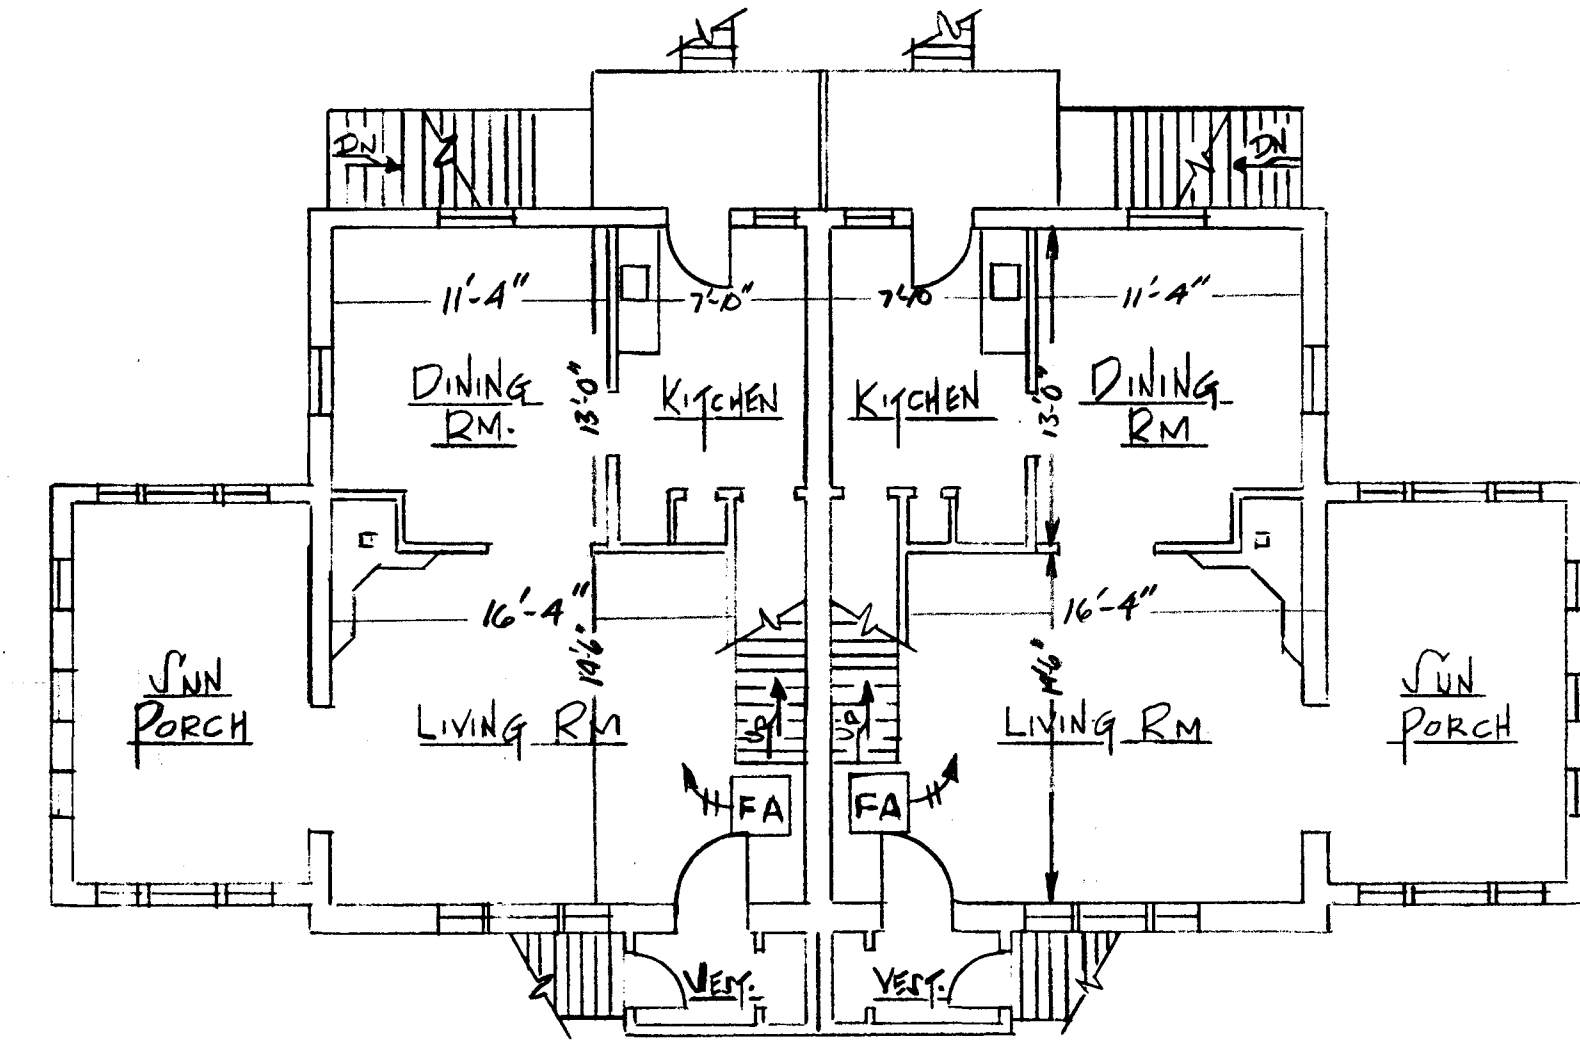

FIRST FLOOR PLAN

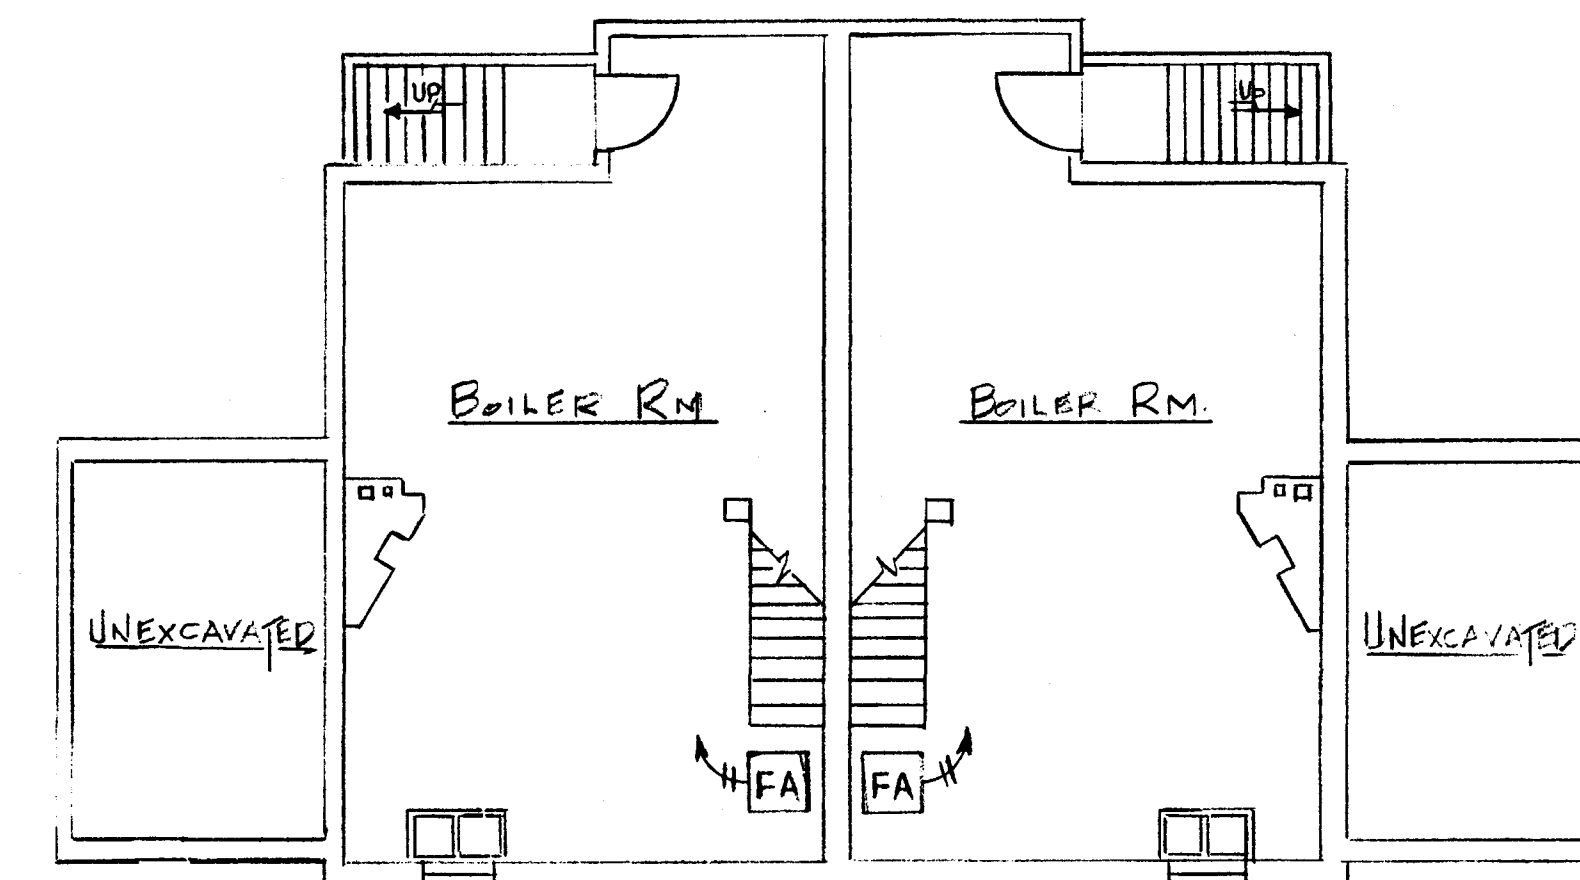

BASEMENT PLAN
FLOOR PLAN BLDGS 276, 277, & 278

NJ013-0149

| DRAWING PLAN CHANGES (SHT 8 & 9) | | | |
|---|-----------------------------------|--------------|-----------------|
| SYMBOL | DESCRIPTION | DATE | APPROVED |
| | | | |
| REVISIONS | | | |
| UNITED STATES ARMY TRAINING CENTER AND FORT DIX DIRECTORATE OF ENGINEERING & HOUSING FORT DIX, N.J. 08540 | | | |
| IMPROVEMENTS TO PEDRICKTOWN USARC FAMILY HOUSING QUARTERS FIRE ALARM SYSTEM PEDRICKTOWN NEW JERSEY | | | |
| DRAWN T.G. | DESIGNED J.E.D. | CHECKED | |
| FP&P DIV | RCAL | B&G DIV | |
| UTL DIV | | USING AGENCY | |
| RECOMMENDED: Robert M. ... | SCALE: 1/8" = 1'-0" | DATE: | DRAWING NUMBER: |
| APPROVED: ... | Director of Engineering & Housing | PR. NR.: | SHEET 12 OF 12 |