


SITE PLAN
SCALE 1" = 20'-0"

- LEGEND**
- INDICATES ABANDONED/REMOVED UNDERGROUND PIPE OR STRUCTURE FROM RECORD DRAWINGS.
 - INDICATES ACTIVE/IN USE UNDERGROUND PIPE OR STRUCTURE FROM RECORD DRAWINGS.
 - INDICATES ITEM/SYSTEM/STRUCTURE TO BE ABANDONED/REMOVED PER SPECIFICATIONS.
 - INDICATES DOUBLE ARM AREA LIGHT STANCHION.
 - INDICATES NEW LINE FOR RE-DIRECTED SEWAGE FLOW.
 - EXISTING CONTOUR ELEVATION (APPROXIMATE).
 - PROPOSED CONTOUR ELEVATION.
 - SILT FENCE.
 - LIMITS OF DISTURBED AREA.
 - LINE SERVICE: S=SANITARY
ST=STORM
W=WATER

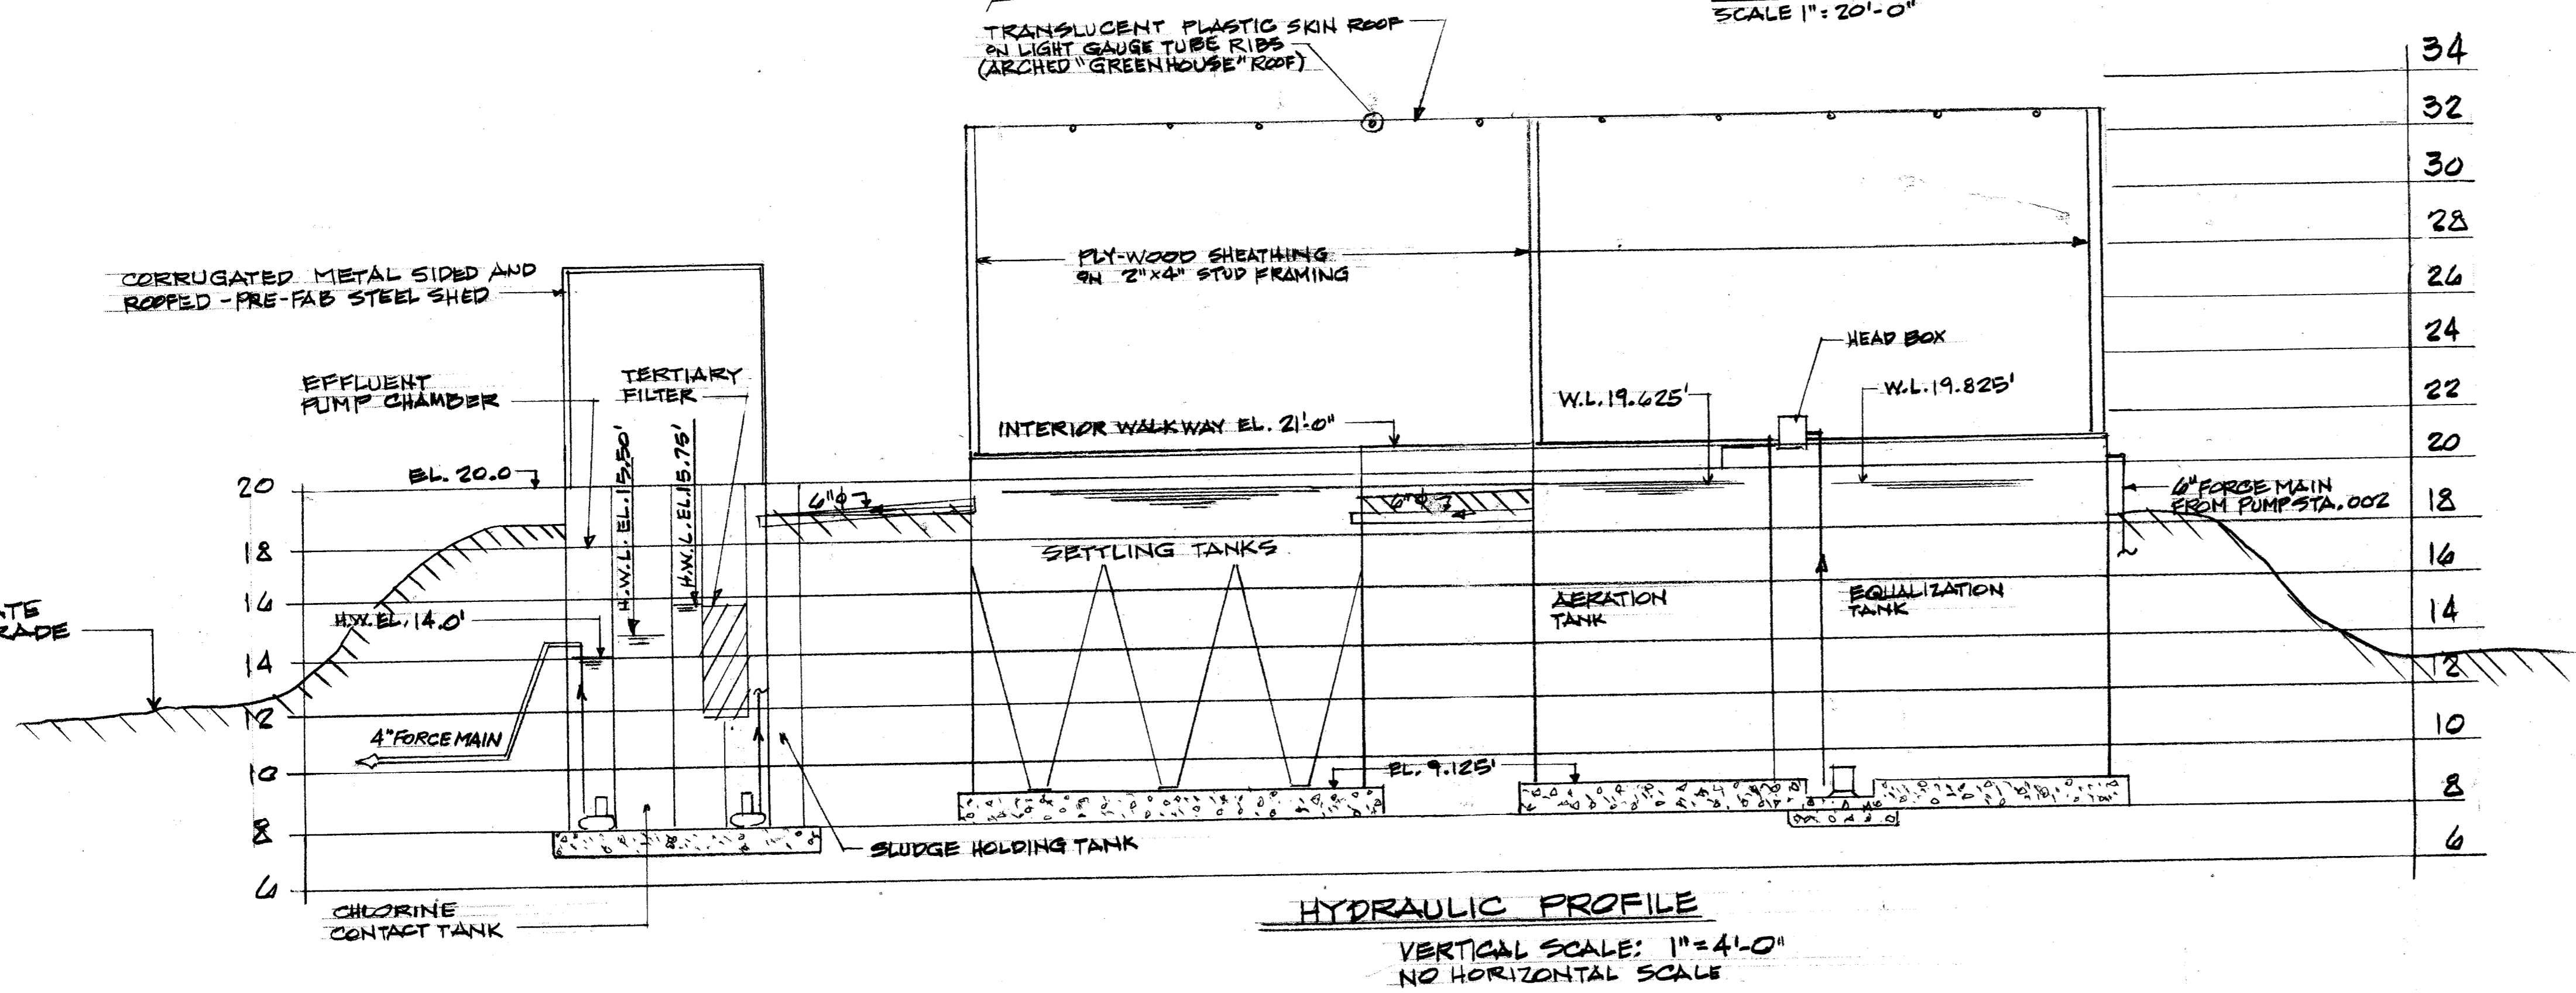

HYDRAULIC PROFILE
VERTICAL SCALE: 1" = 4'-0"
NO HORIZONTAL SCALE

NJ013-0711

SYMBOL	DESCRIPTION	DATE	APPROVED
REVISIONS			
FOSTER WHEELER USA CORPORATION PERRYVILLE CORPORATE PARK, CLINTON, N.J.		UNITED STATES ARMY - FORT DIX DIRECTORATE OF PUBLIC WORKS FORT DIX, NEW JERSEY 08640	
DRAWN	N. A.	NEW WASTEWATER LIFT STATION AND FORCE MAIN SEIVERS-SANDBERG U.S. ARMY RESERVE CENTER PEDRICKTOWN, NEW JERSEY	
DESIGNED	N. A.		
CHECKED	P. F. E.		
FP&P DIV			
B&G DIV			
UTIL. DIV		DEMOLITION SITE PLAN/HYDRAULIC PROFILE	
USING AGENCY			
RECOMMENDED:	Chief Engineering, Plans & SERVICES	SCALE: AS NOTED	DRAWING NUMBER
APPROVED:	Director of Engineering & Housing	DATE: OCT. 25, '96	PLATED-1
		PR. NR: GM-00036-5P	SHEET 4 OF 18

13-05-37389